

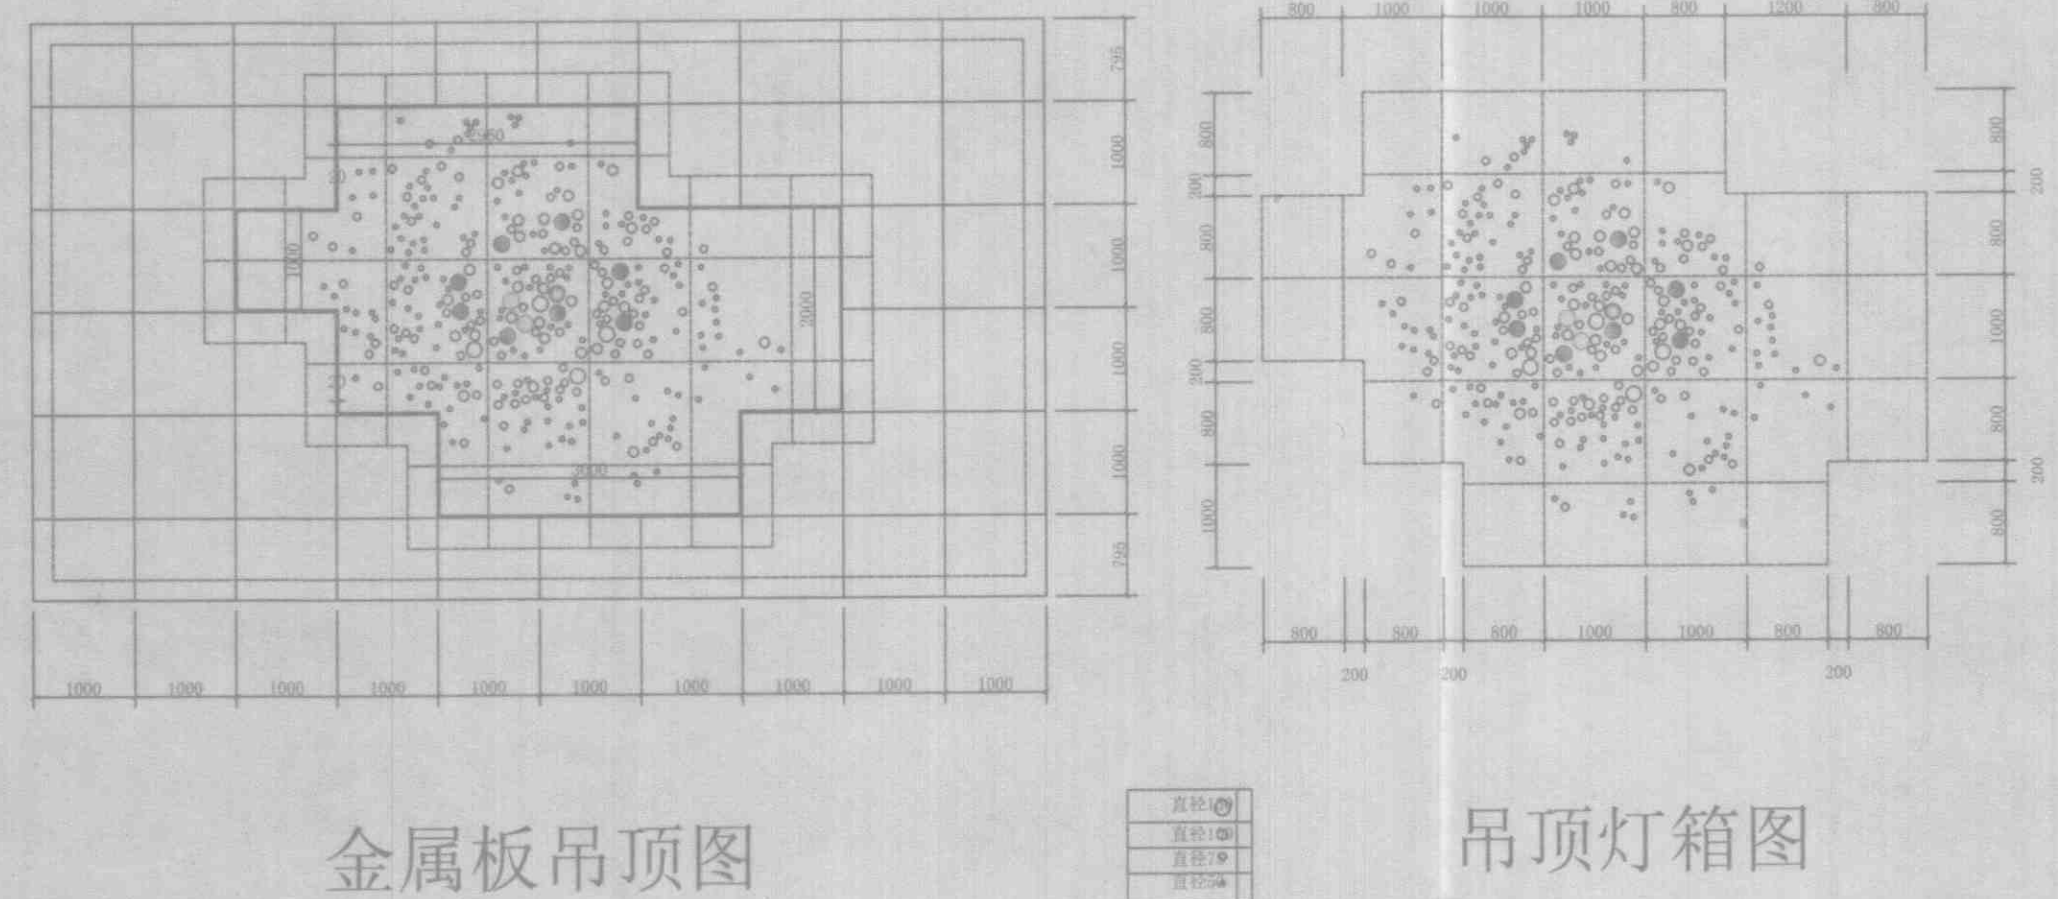
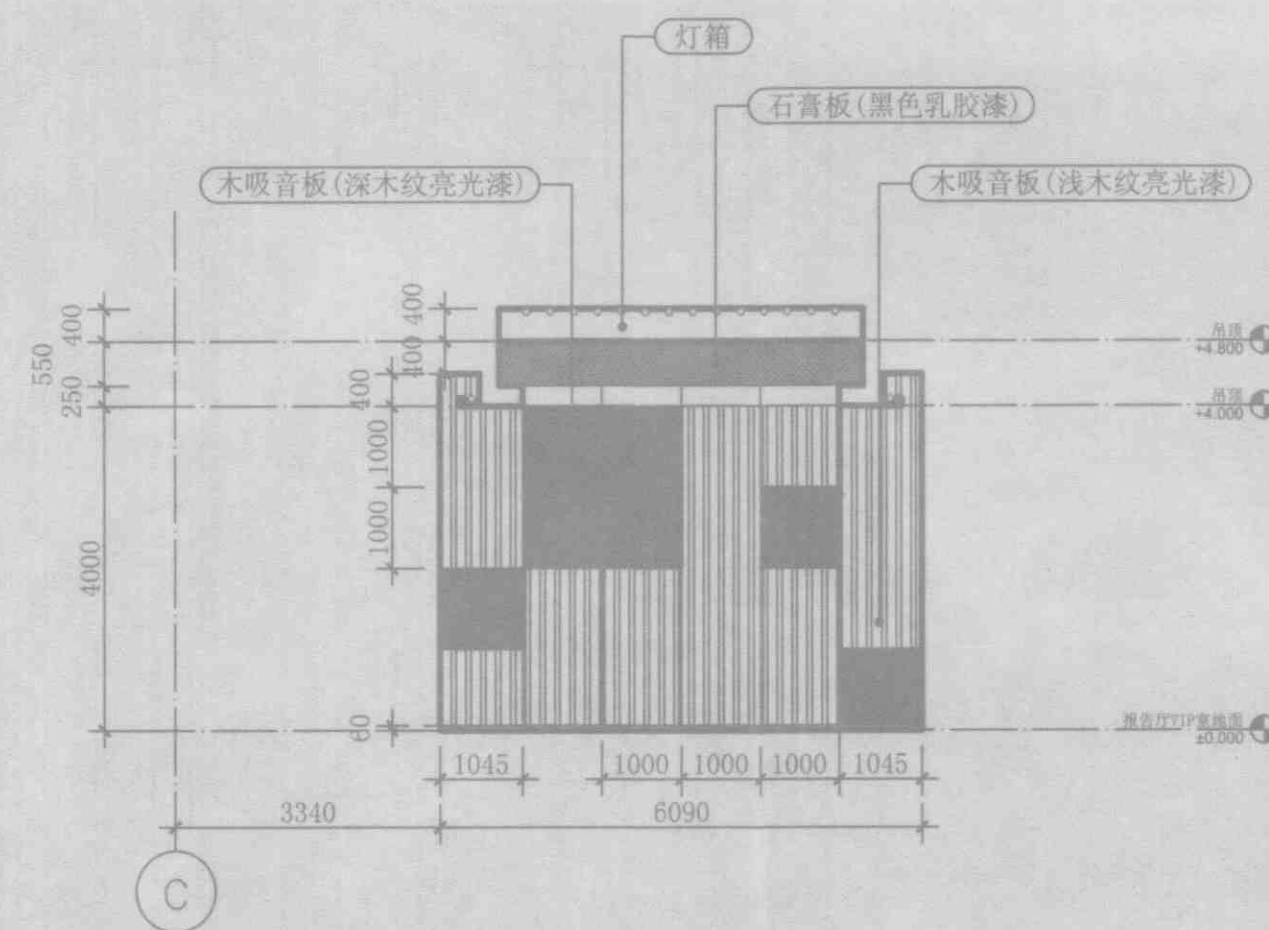
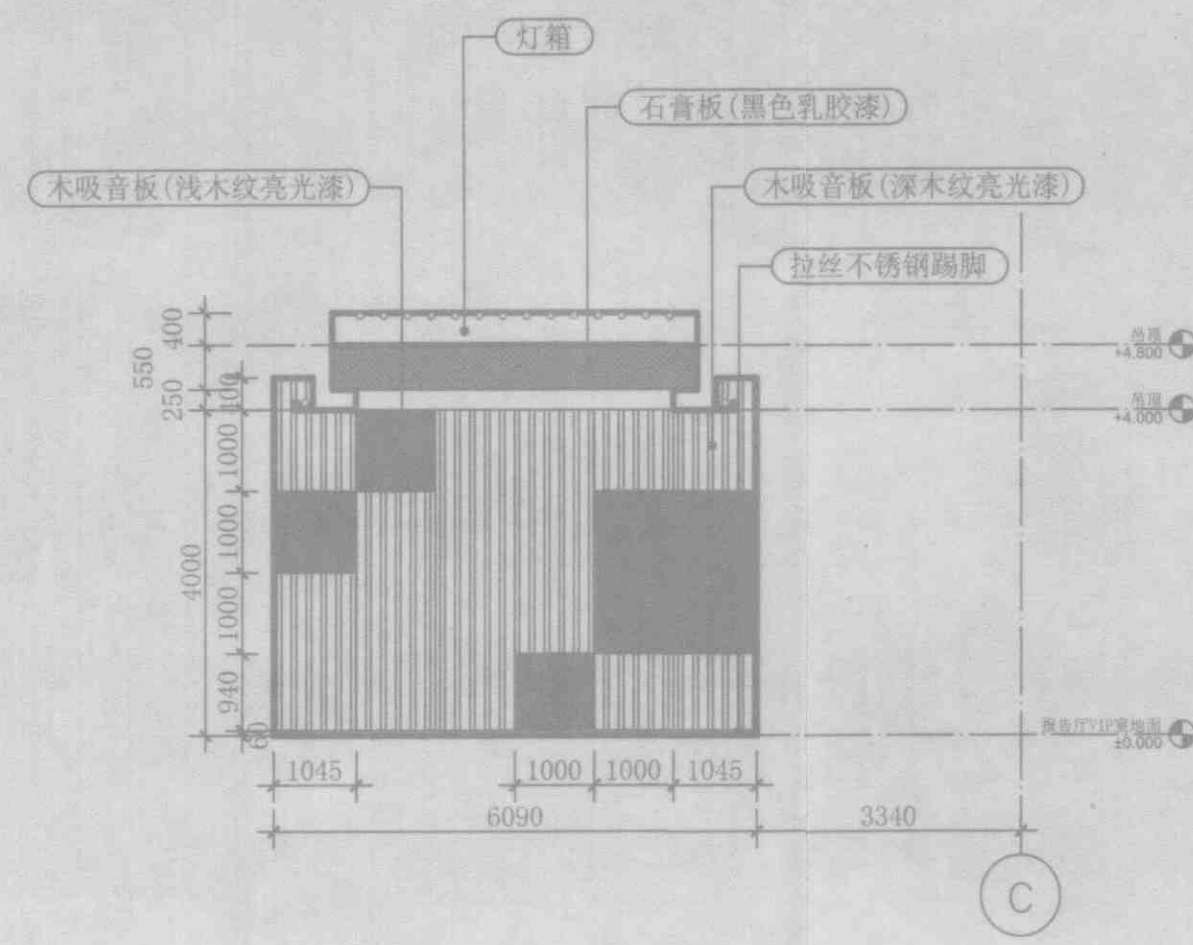
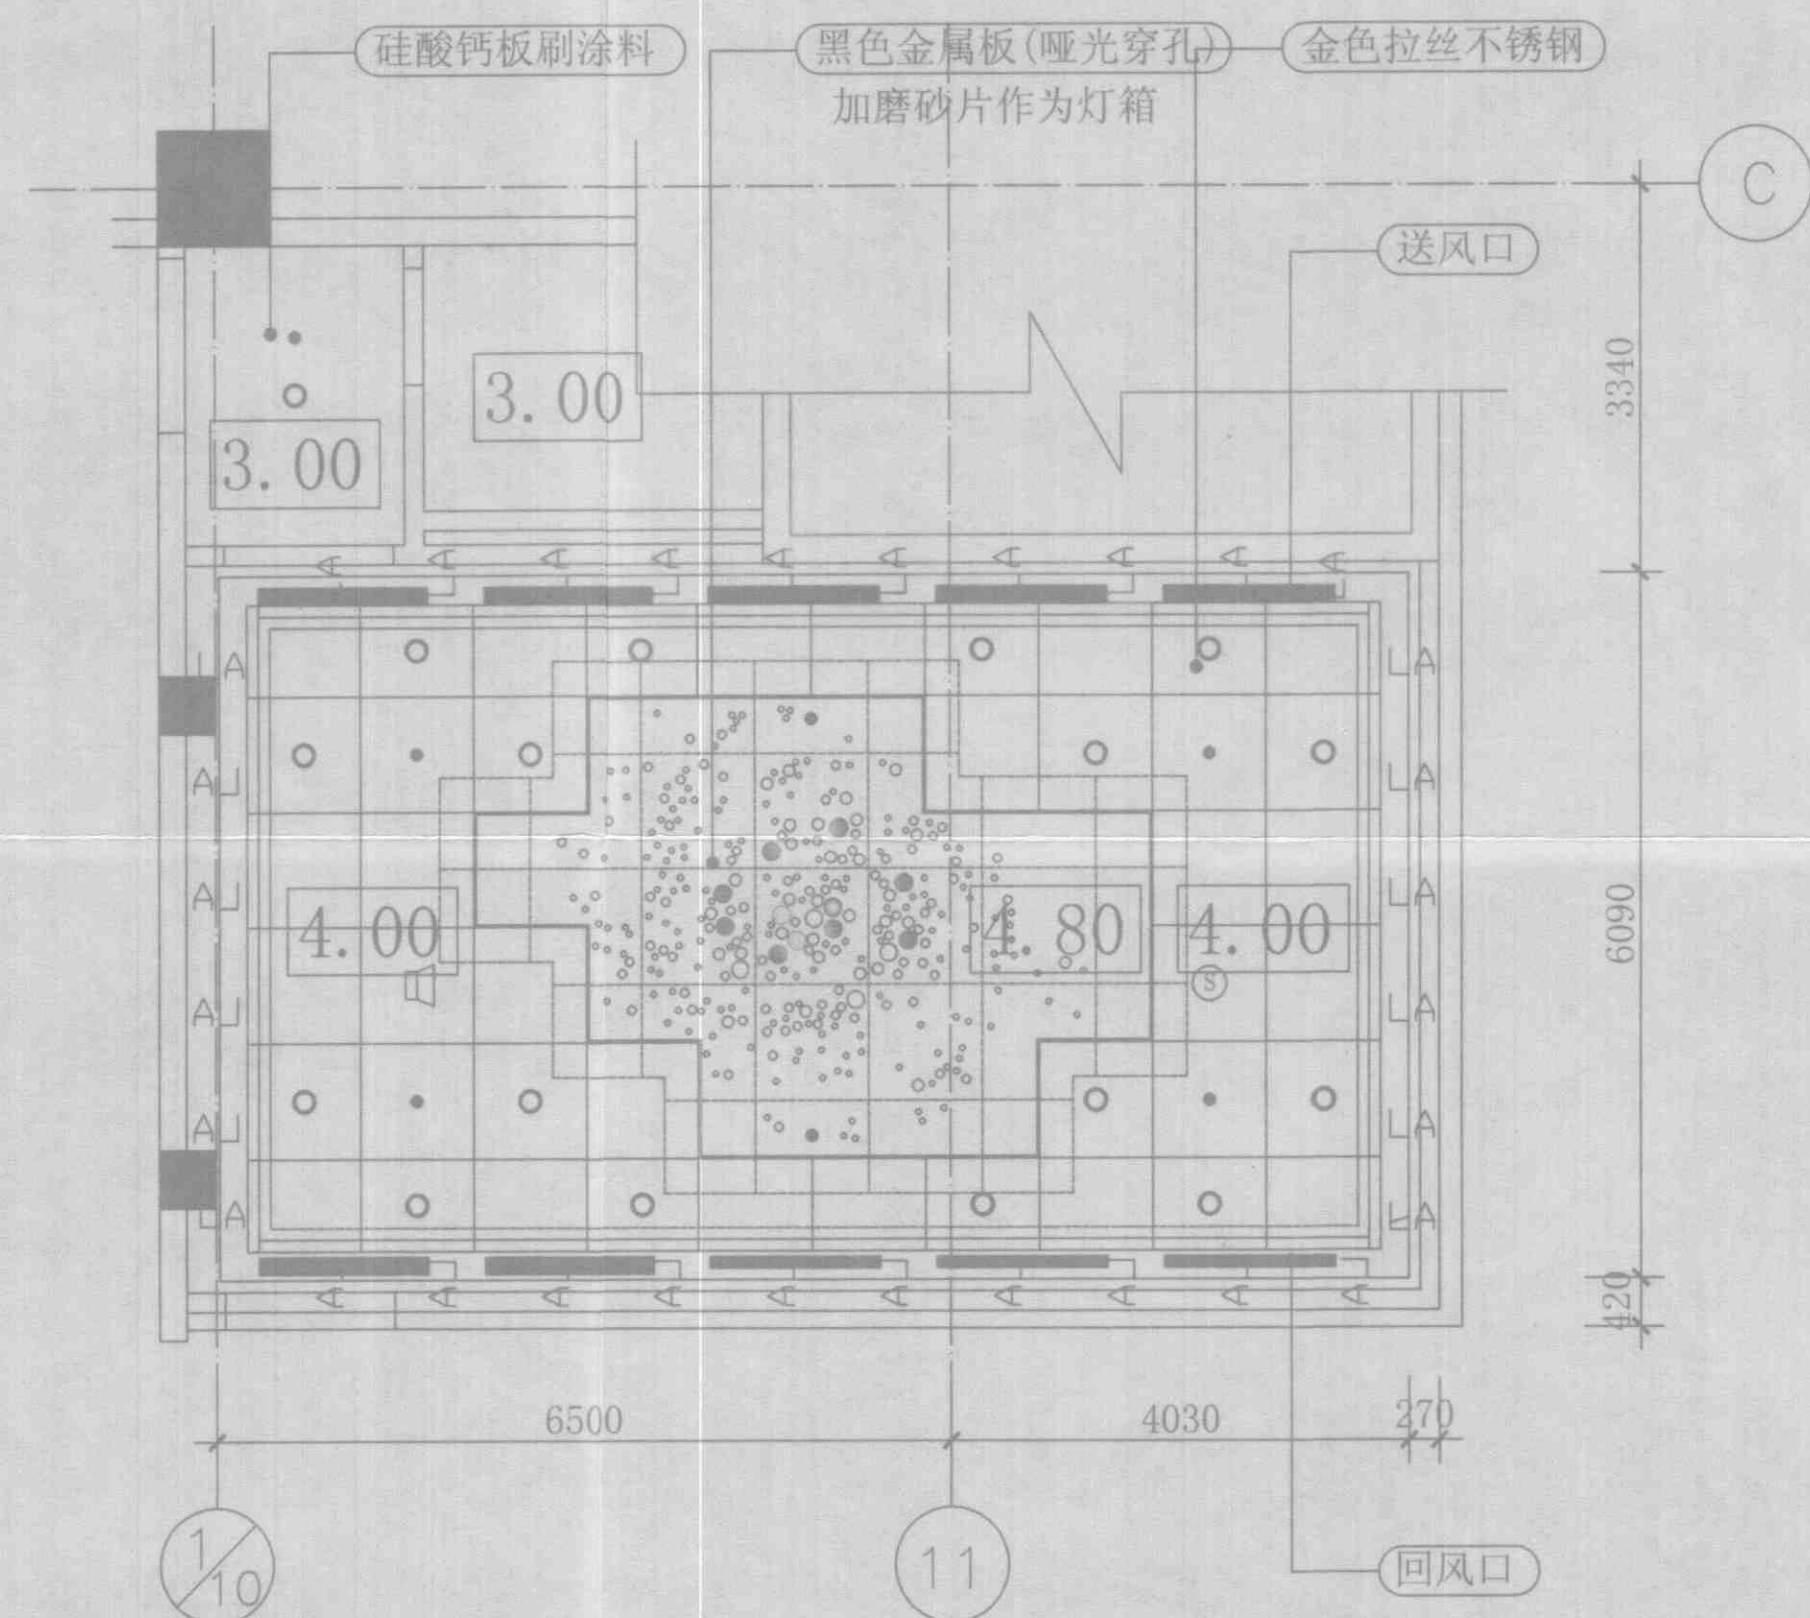
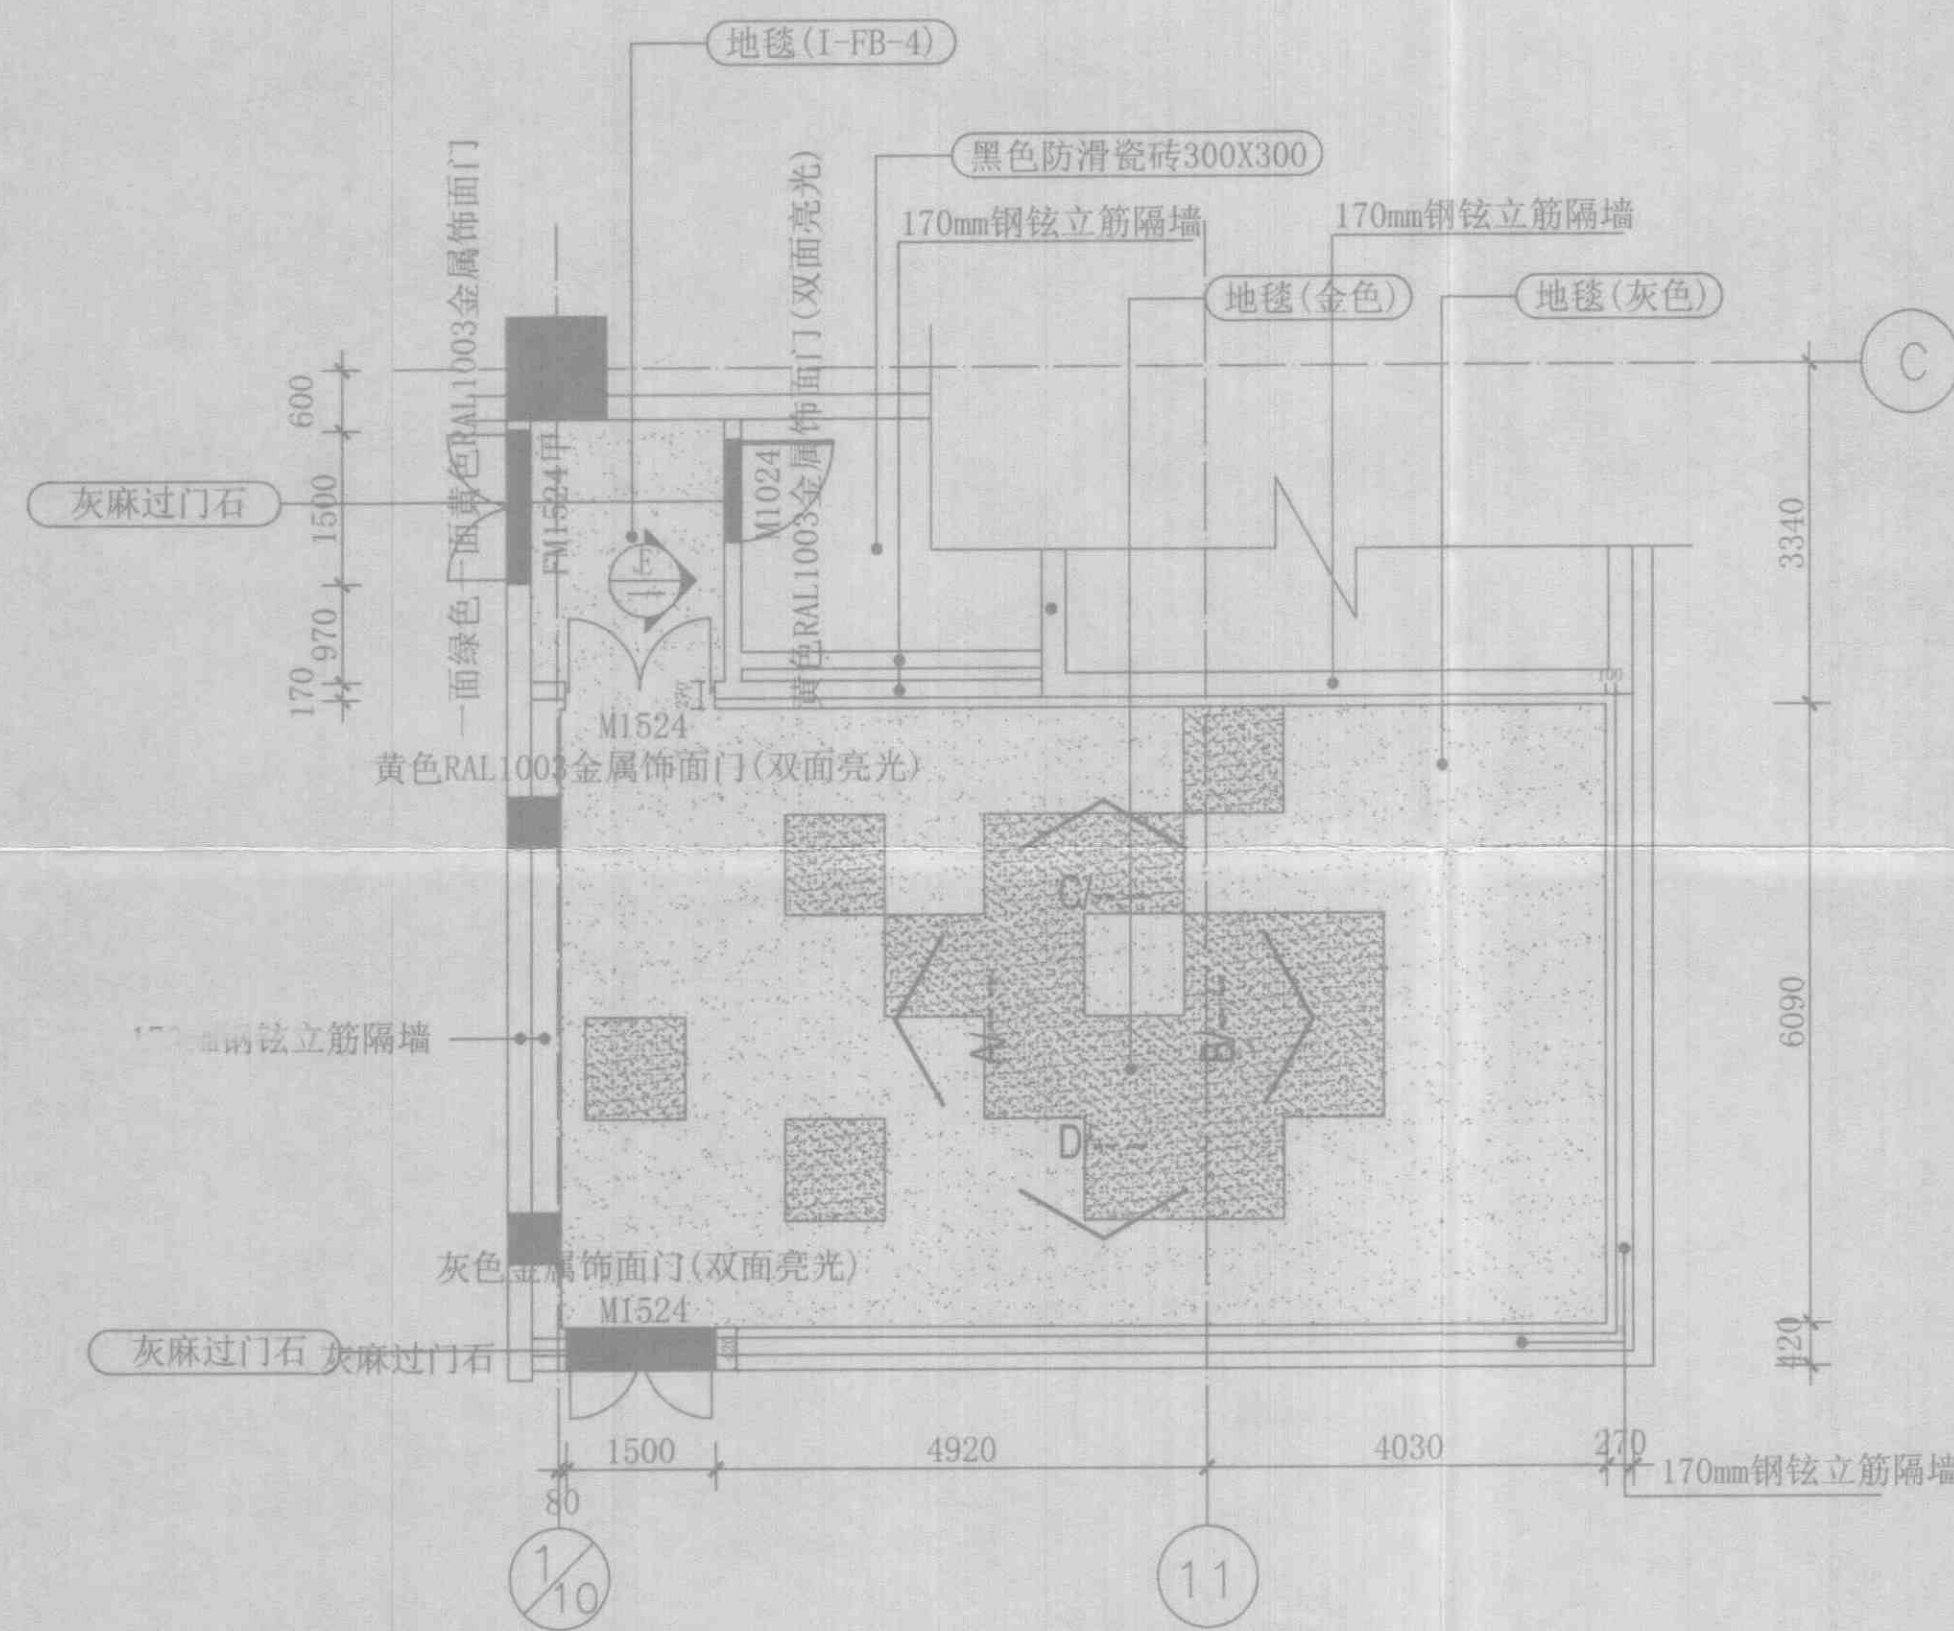
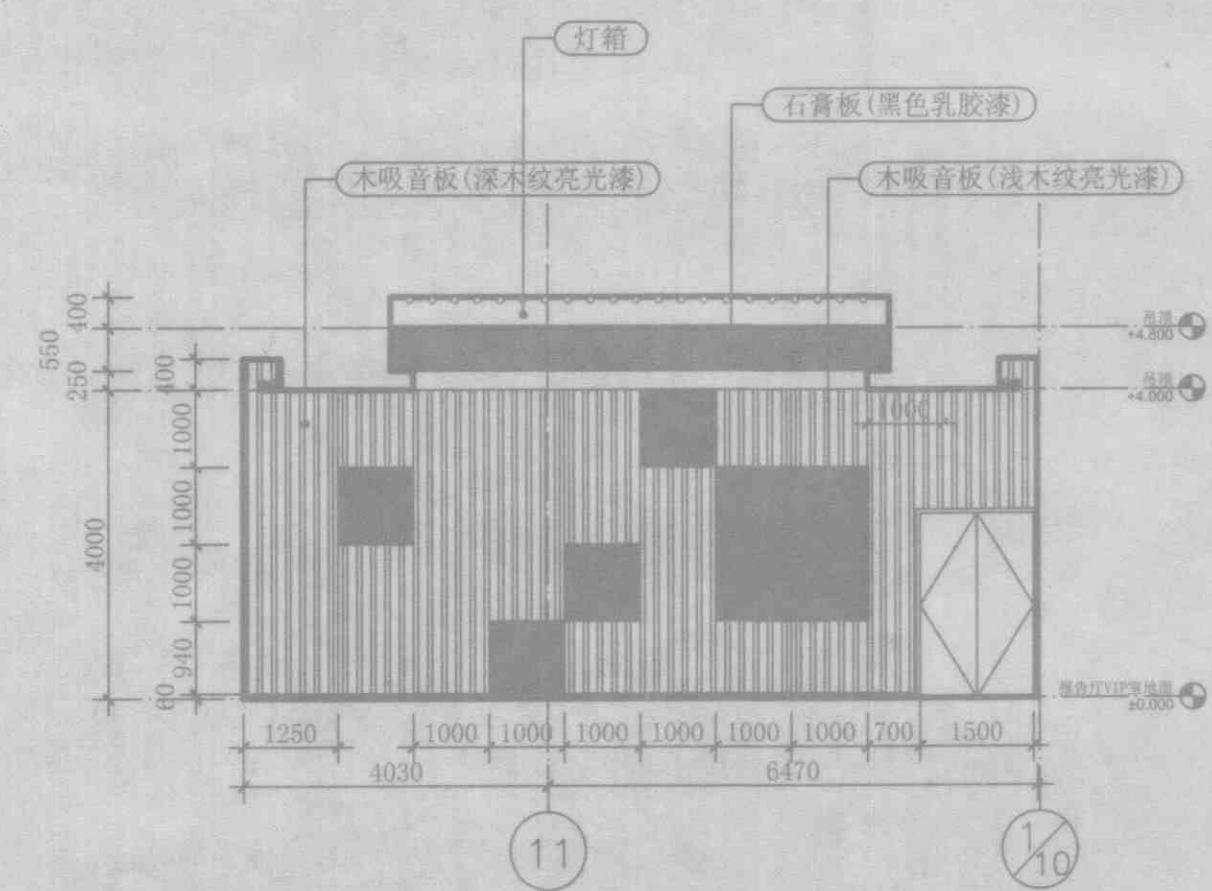
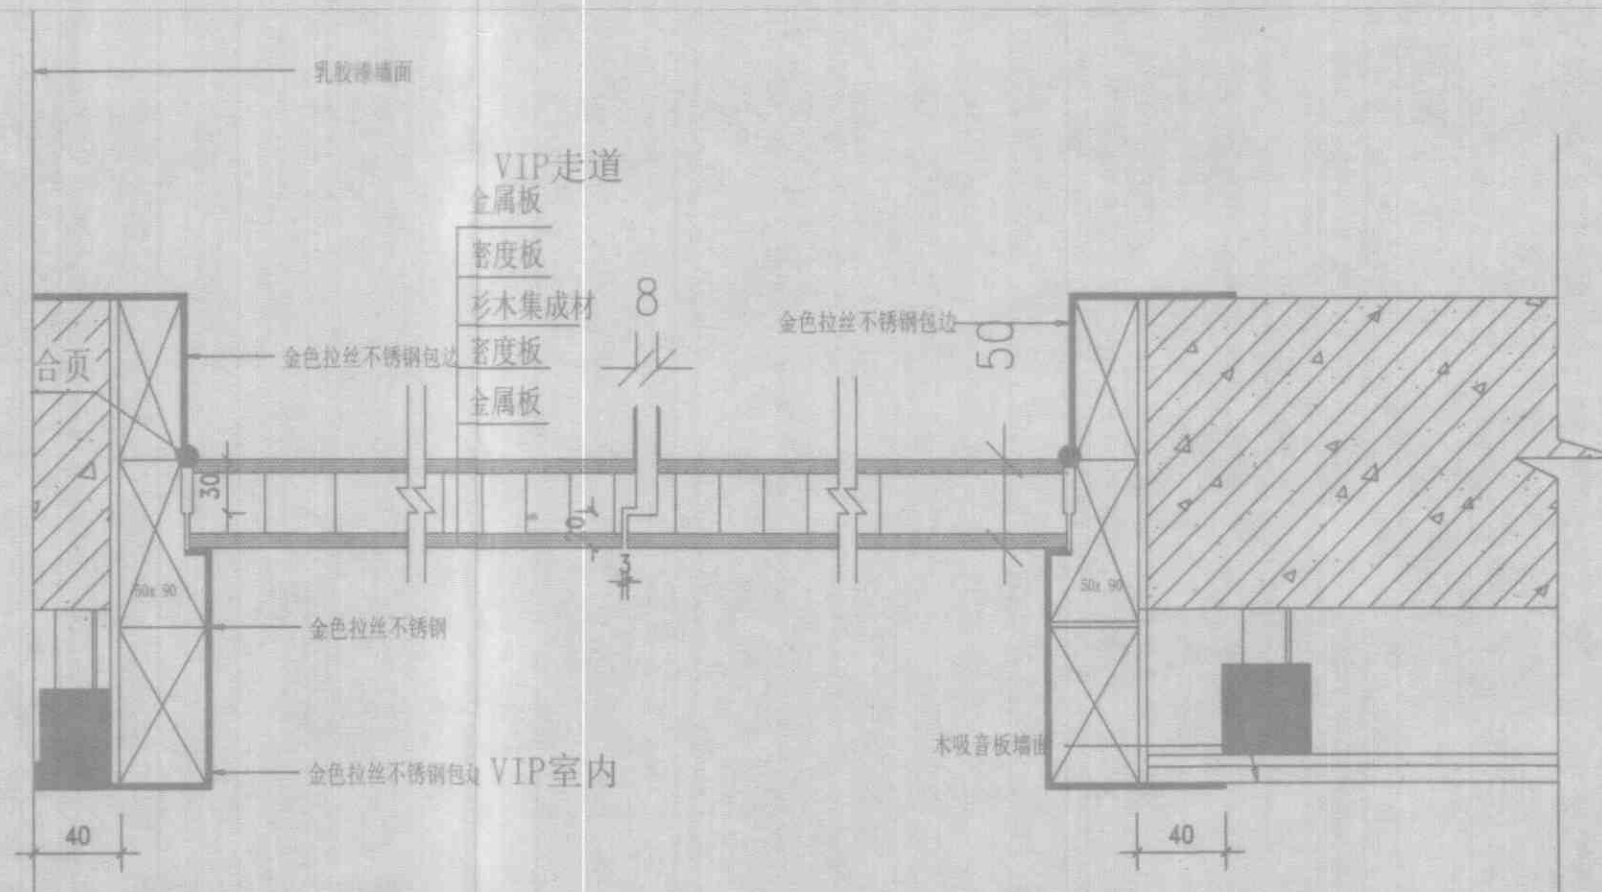
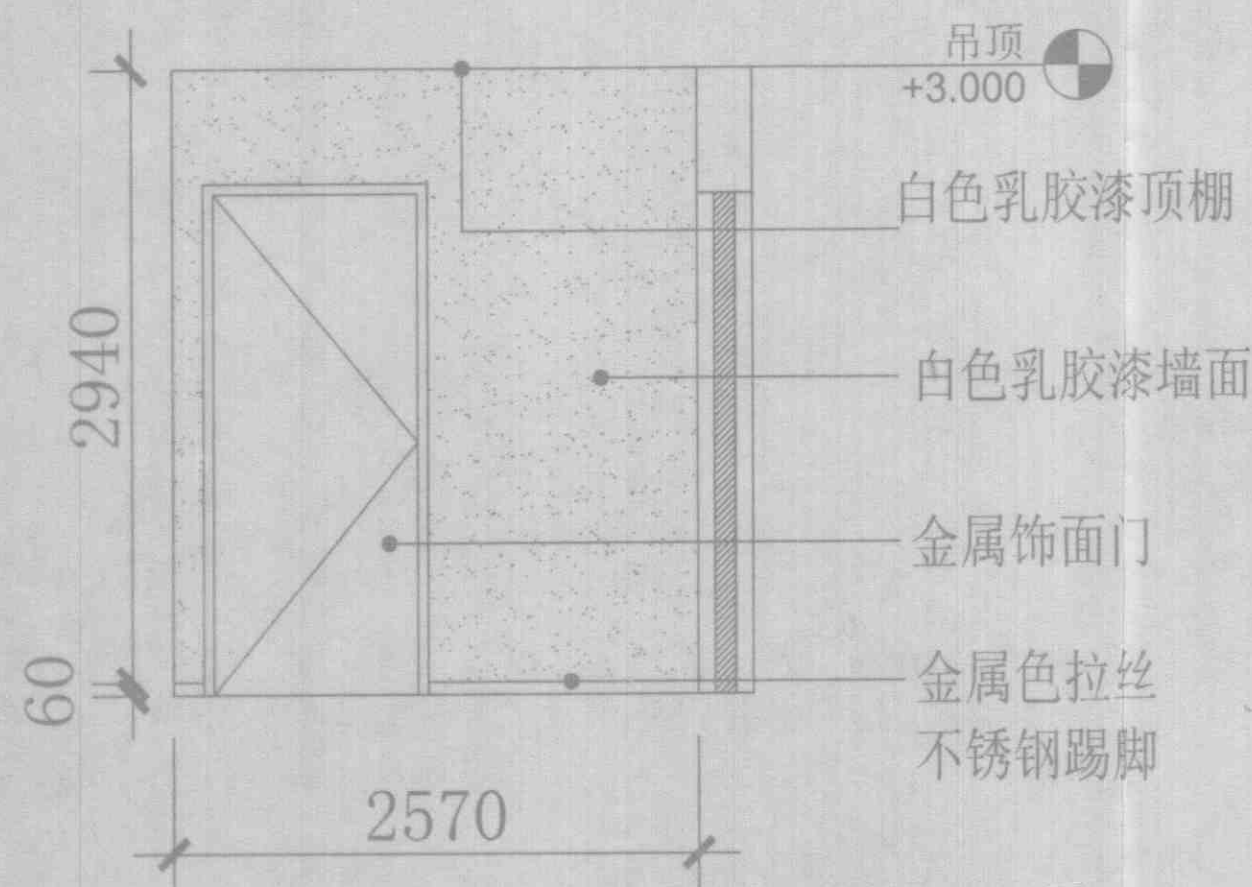


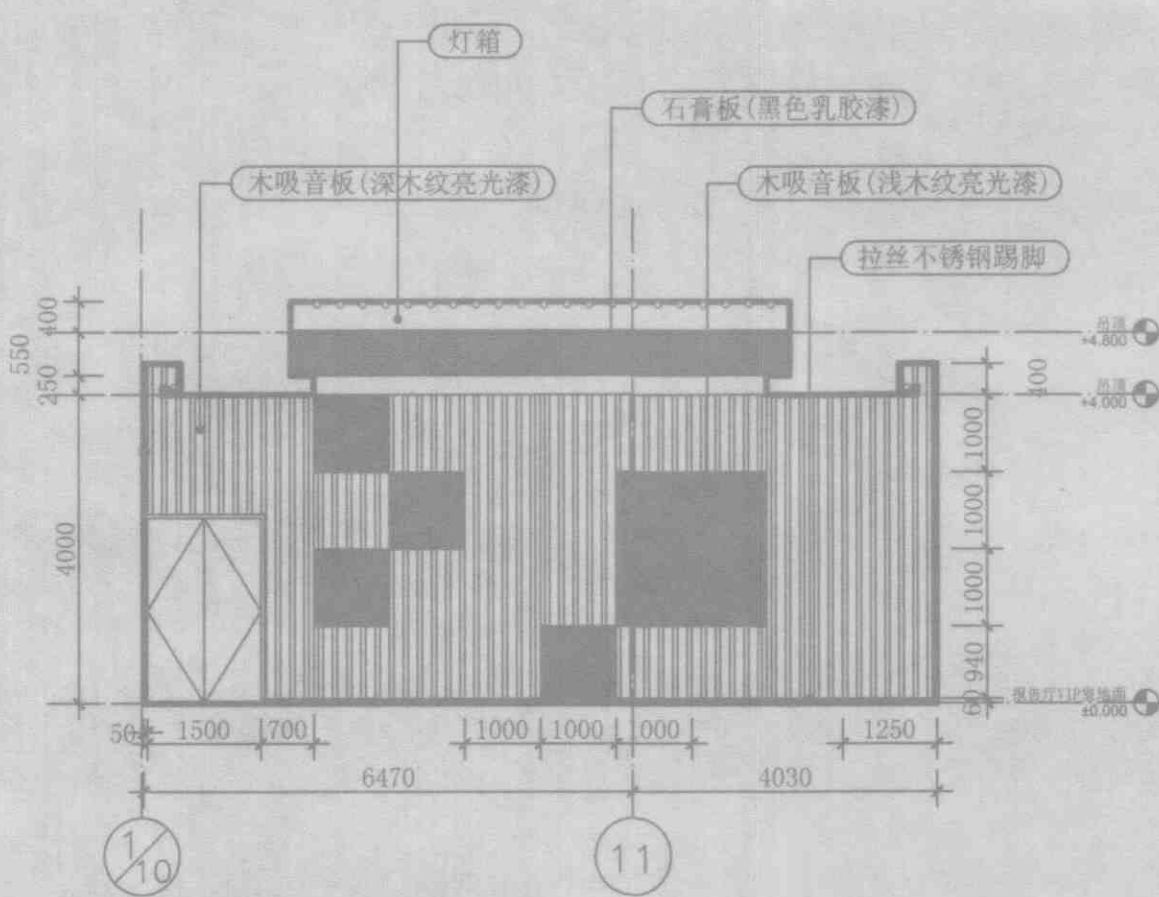

吊顶灯箱图

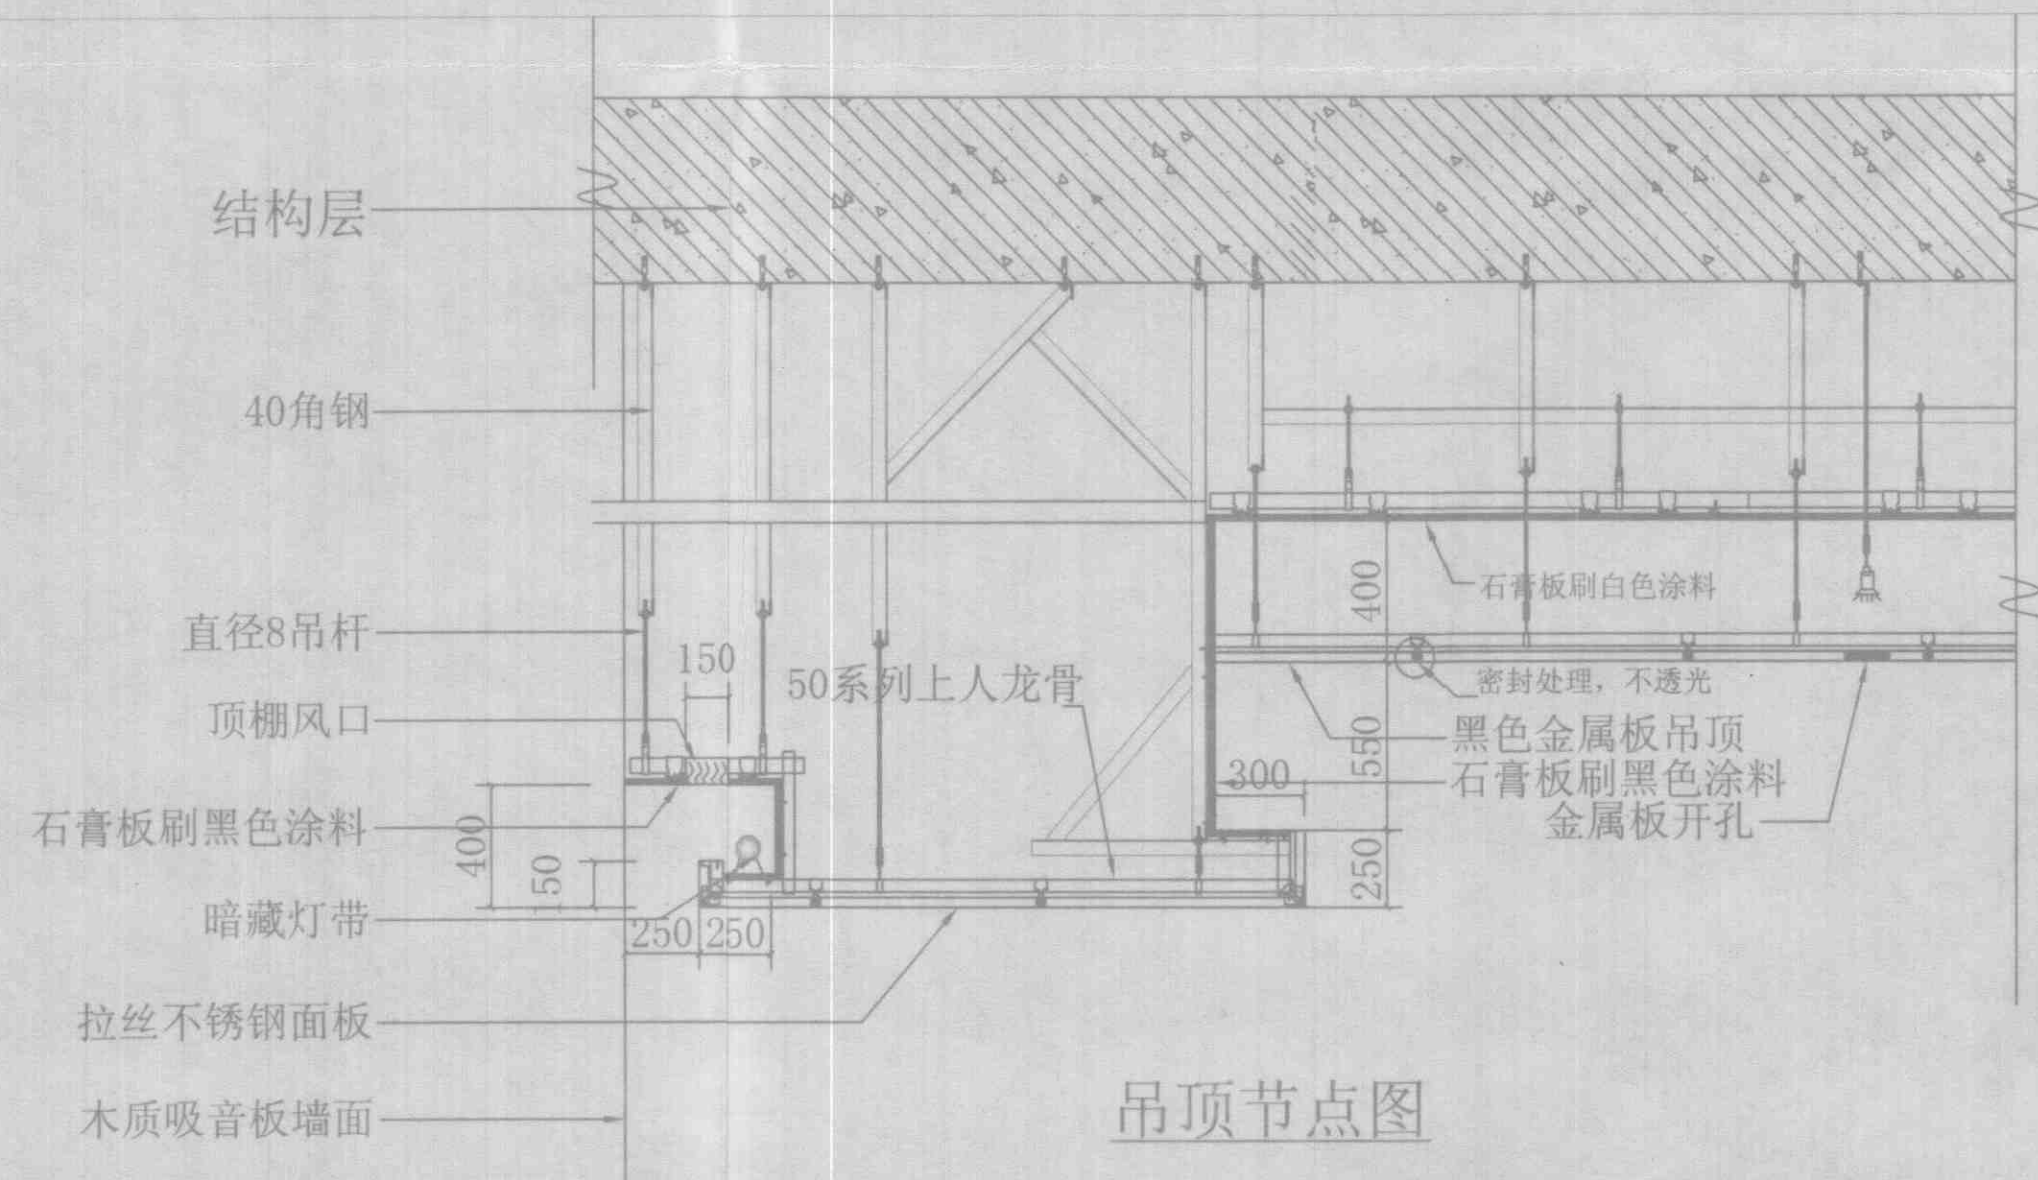

**竣工图**

北京城建四建设工程有限公司

制 图 人: 张维

审 核 人: 张维

技术负责人: 张维

2009.08.04

中国科技馆新馆

工程编号: 2006001

报告厅VIP室

设计阶段: 施工图

图号: 11


设计日期: 2009年08月04日

审核日期: 2009年08月04日


制图日期: 2009年08月04日

比例: 1/100  
SCALE: 1/100




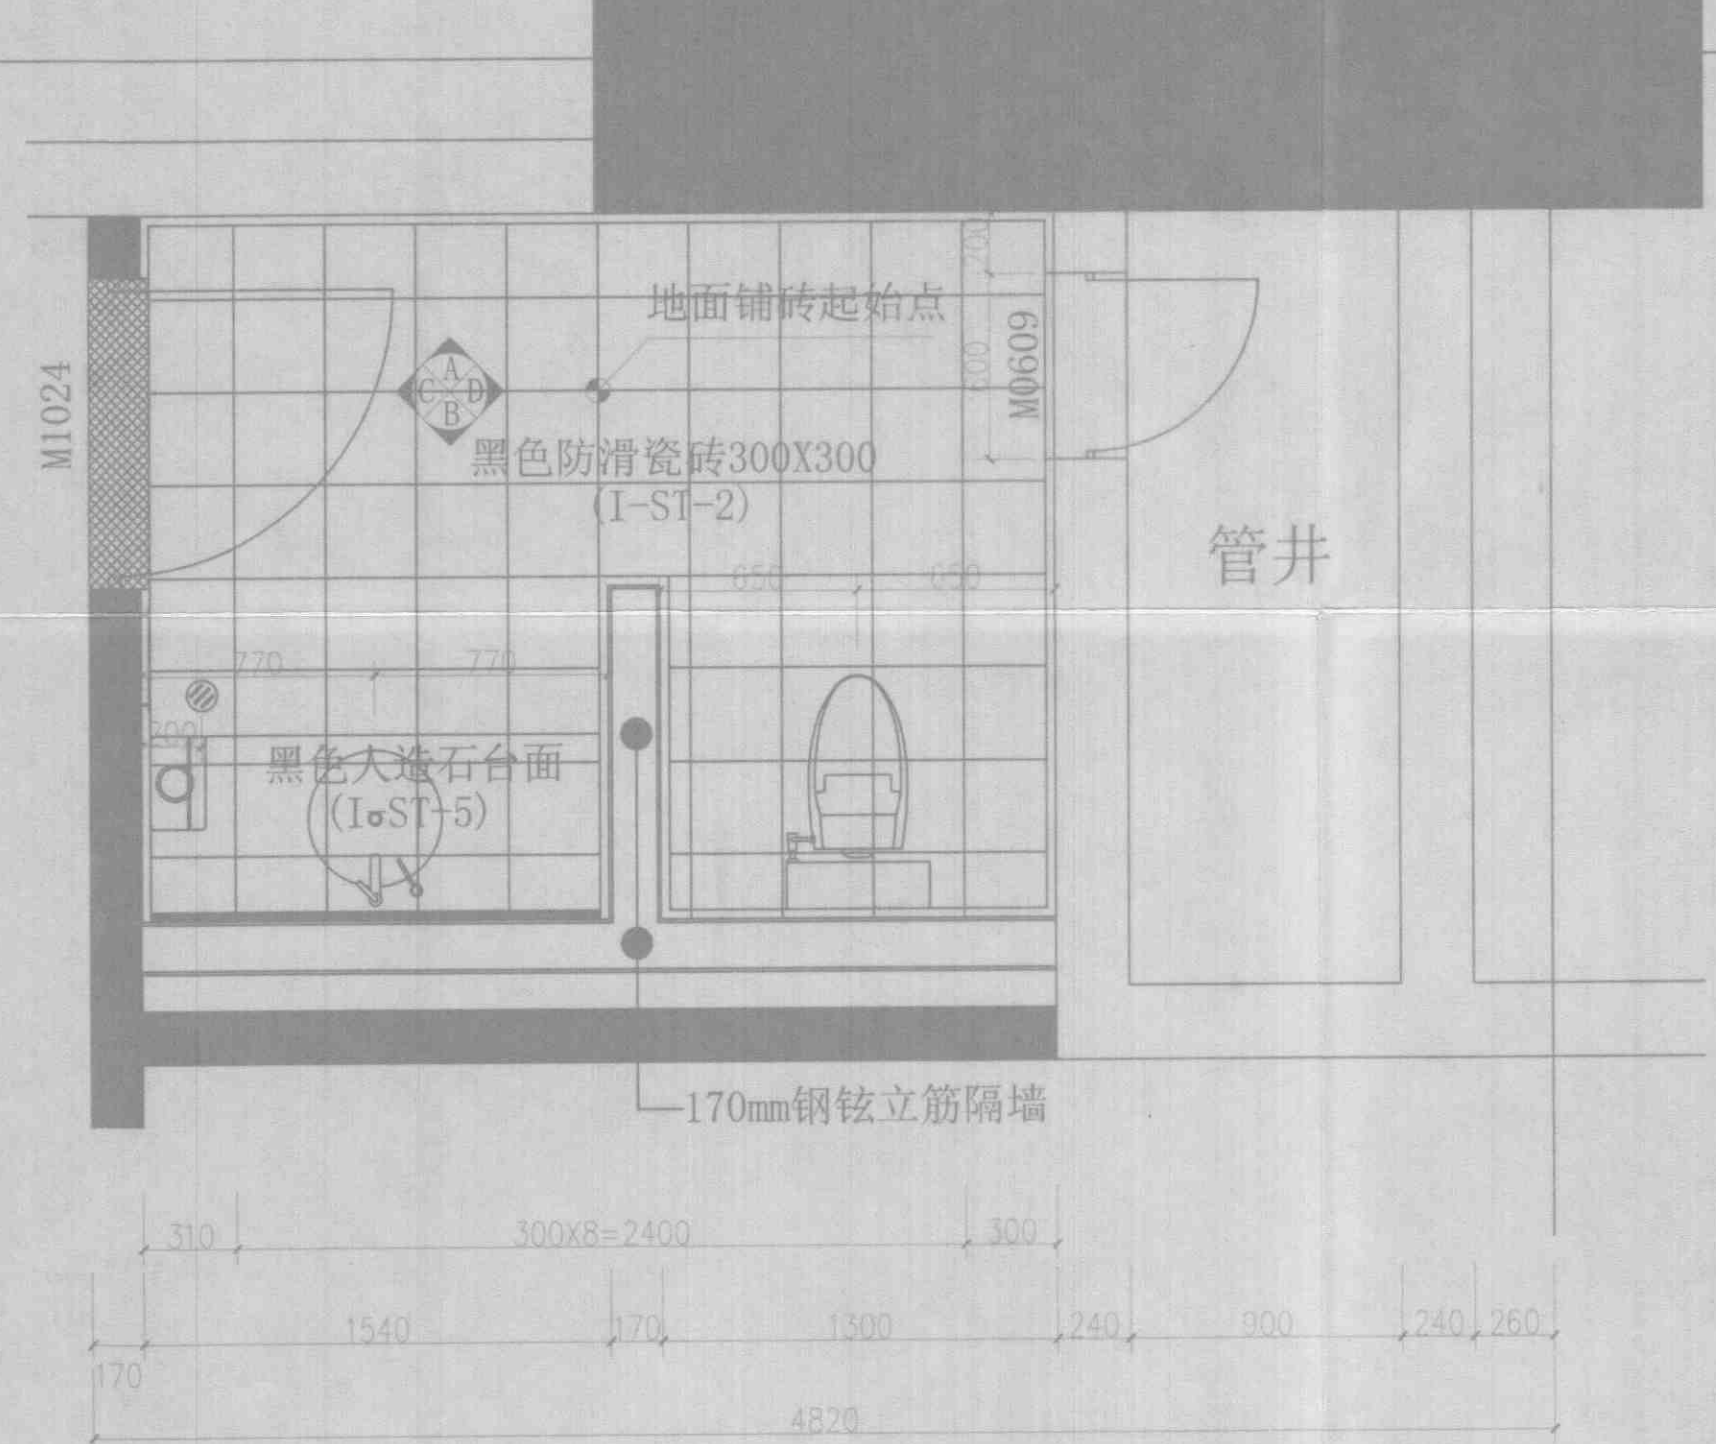


1-19#卫生间平面图  
1:30

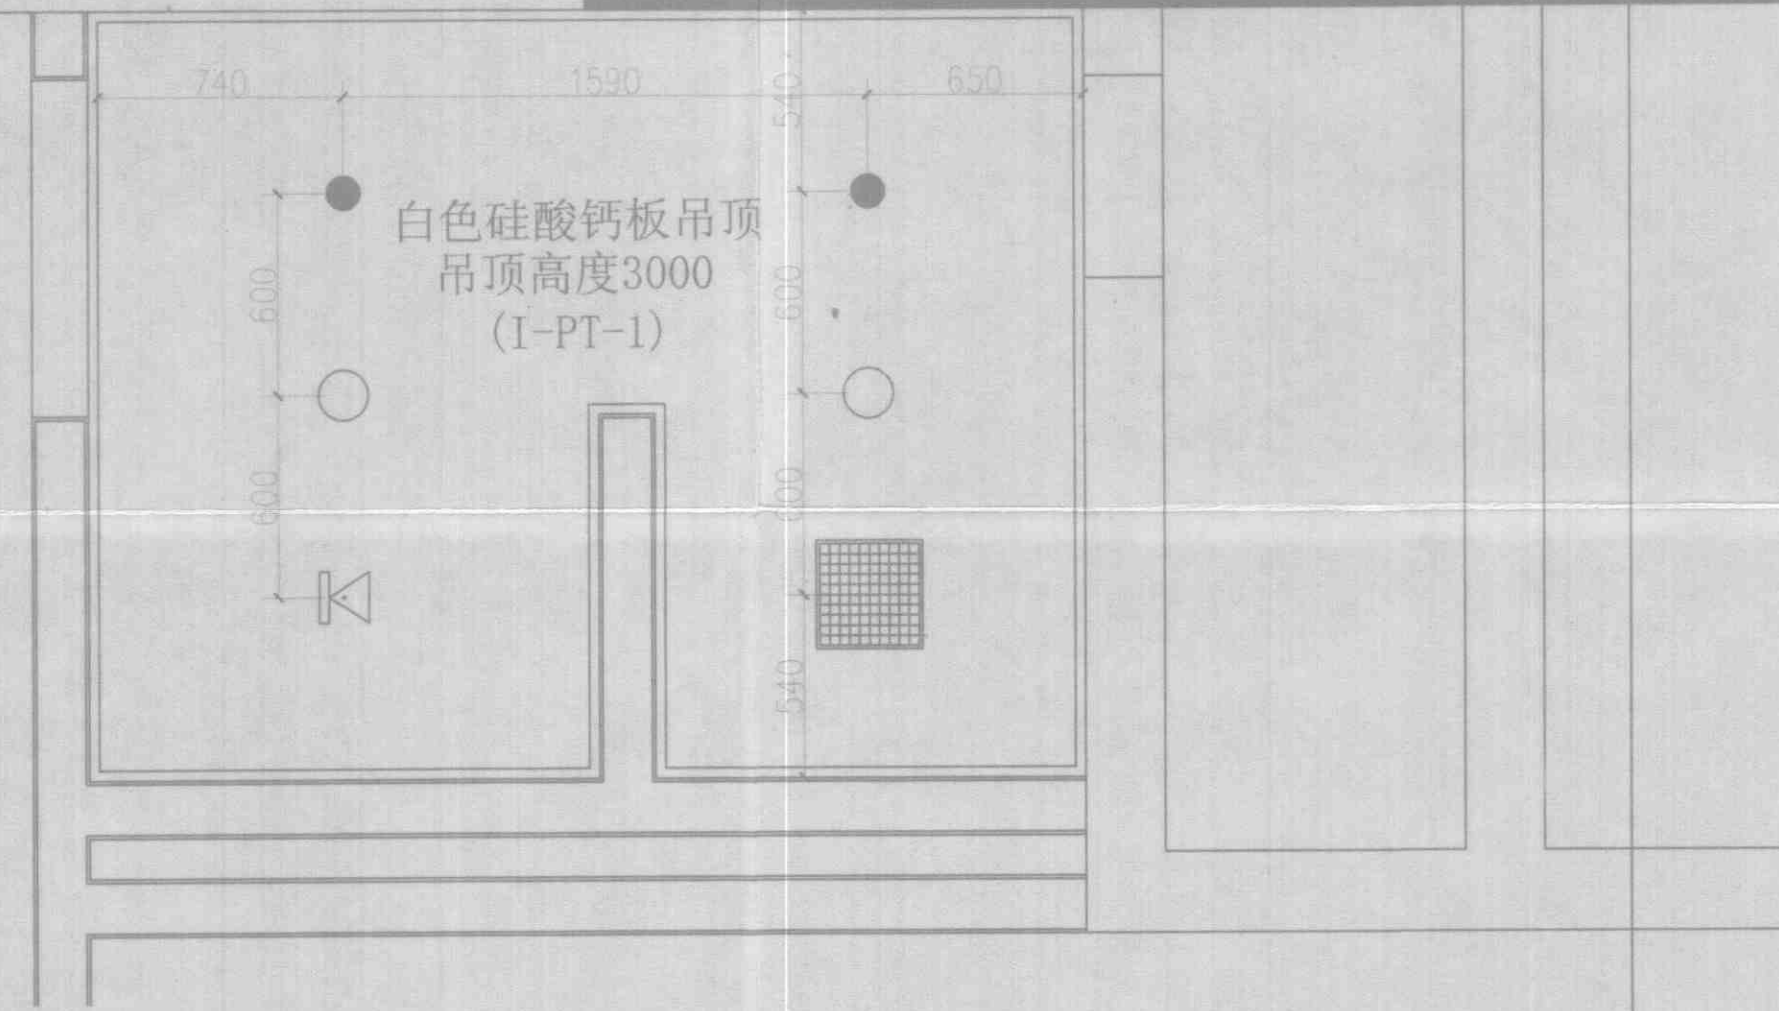


1-19#卫生间吊顶图  
1:30

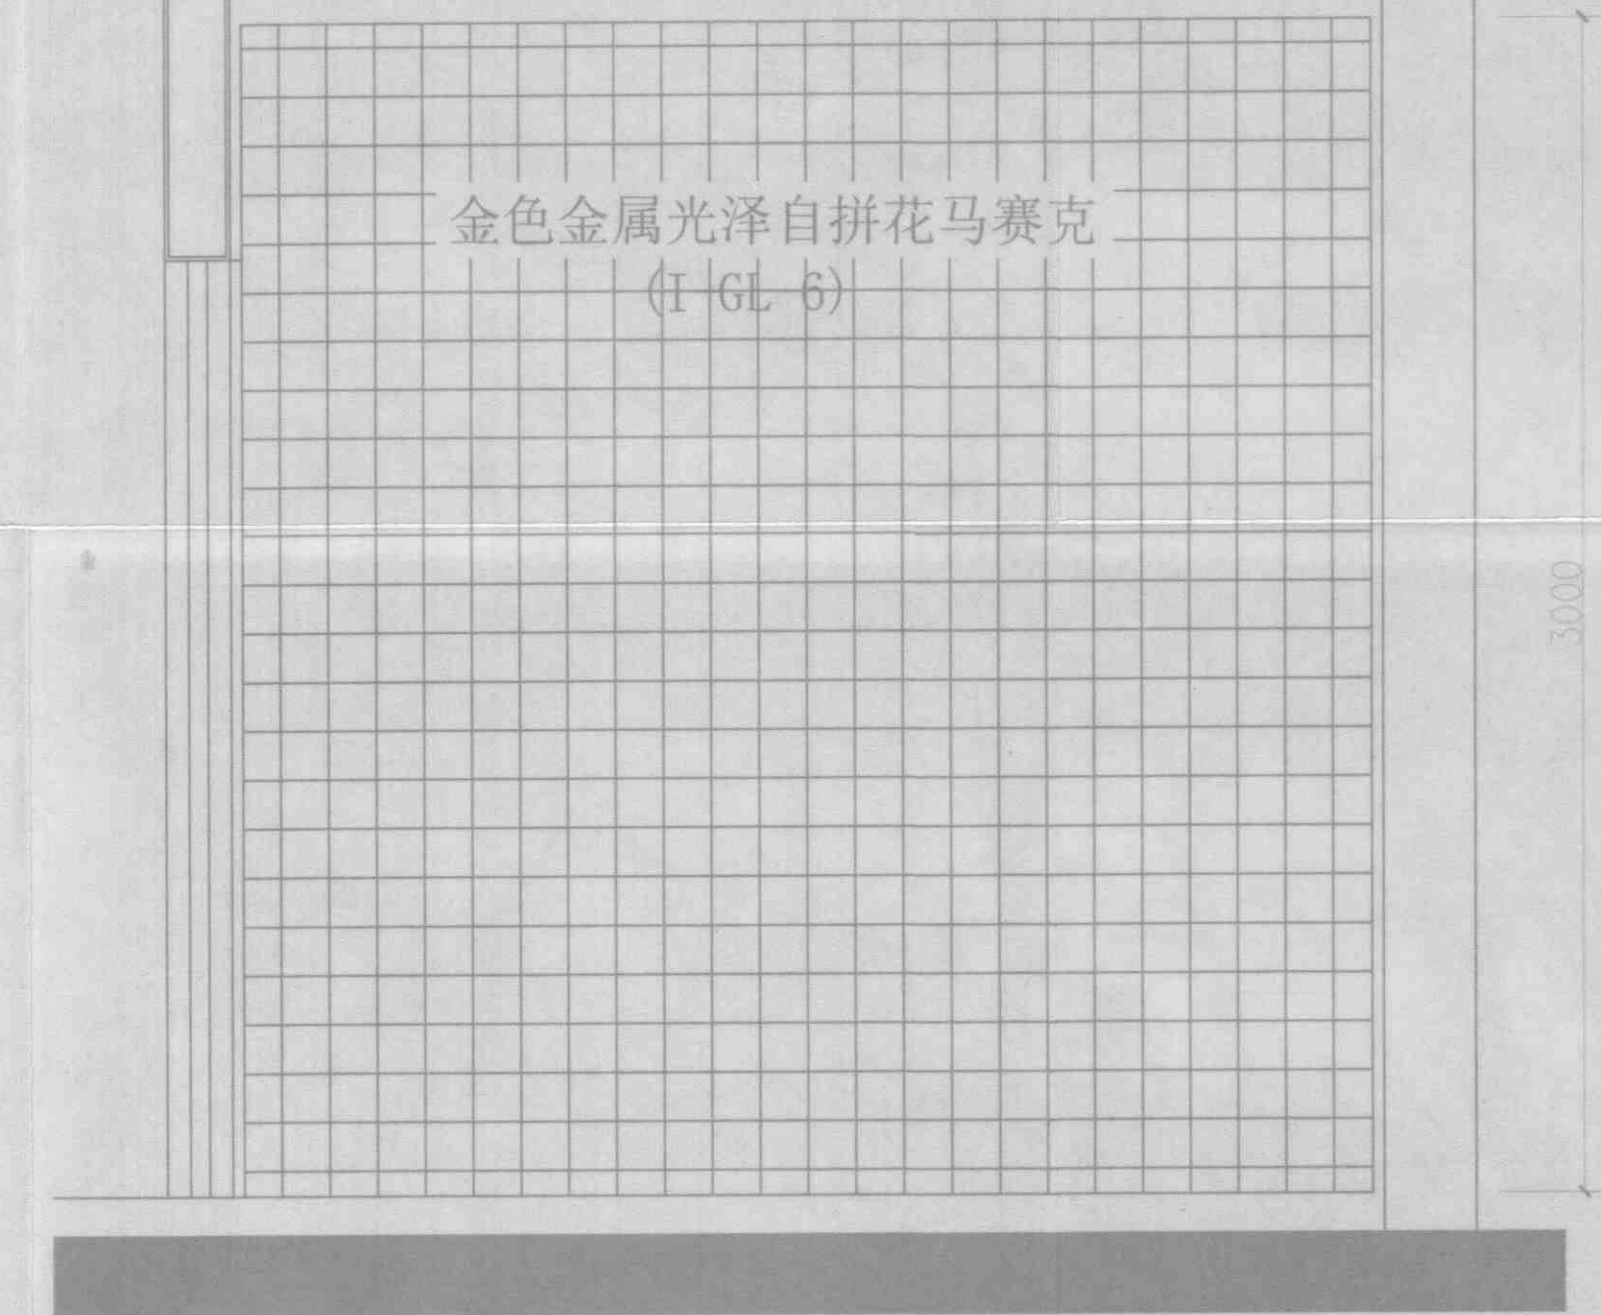


卫生间立面图  
1:30

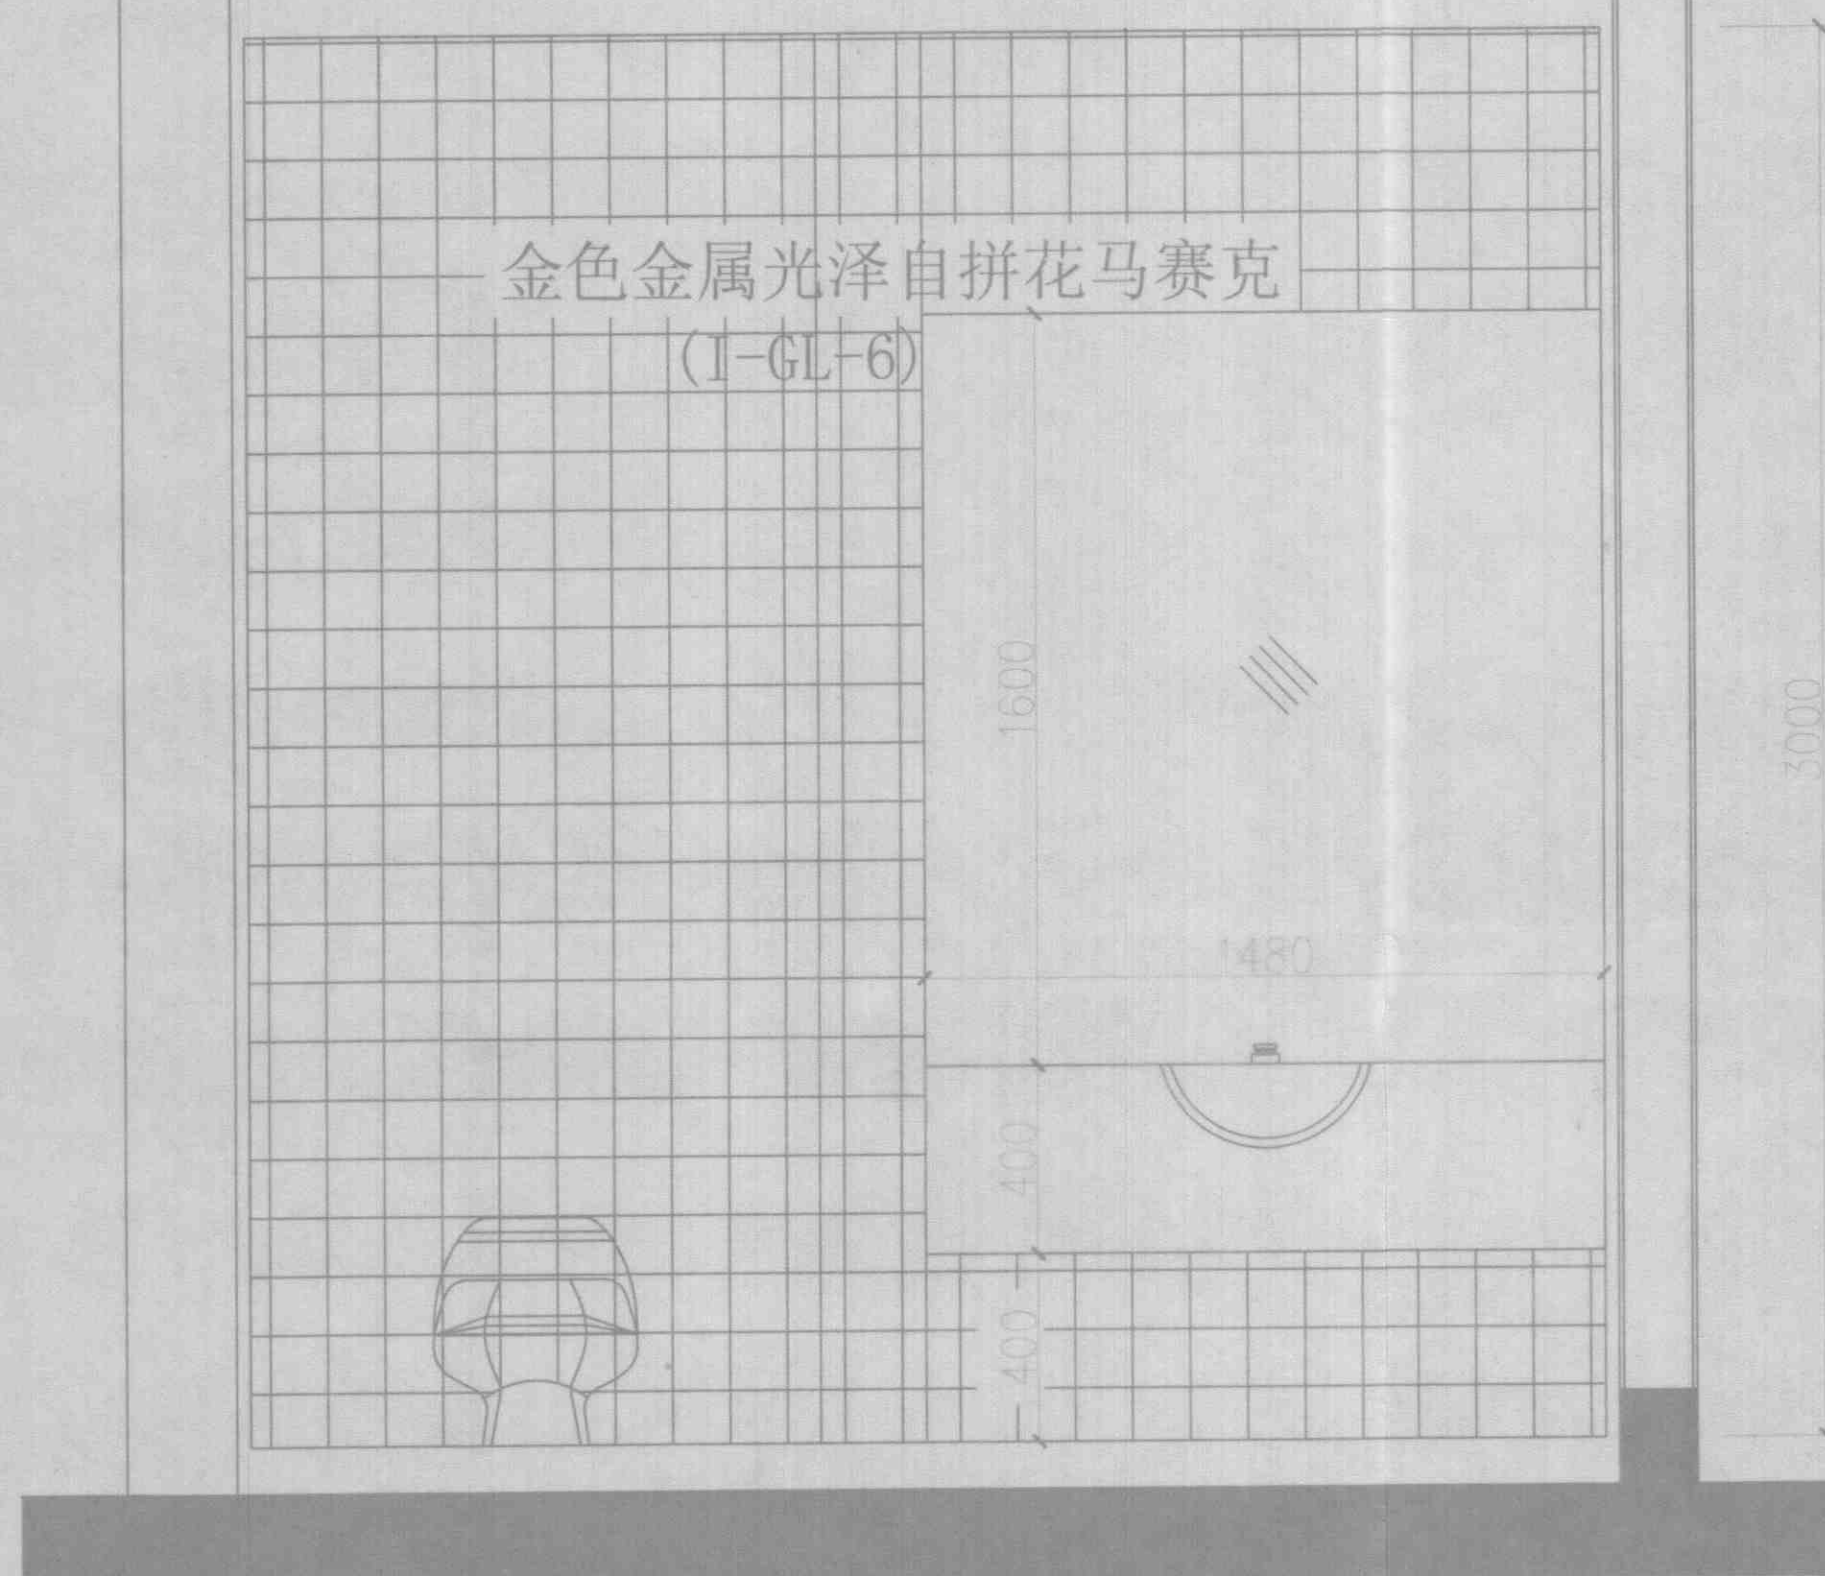

卫生间立面图  
1:30

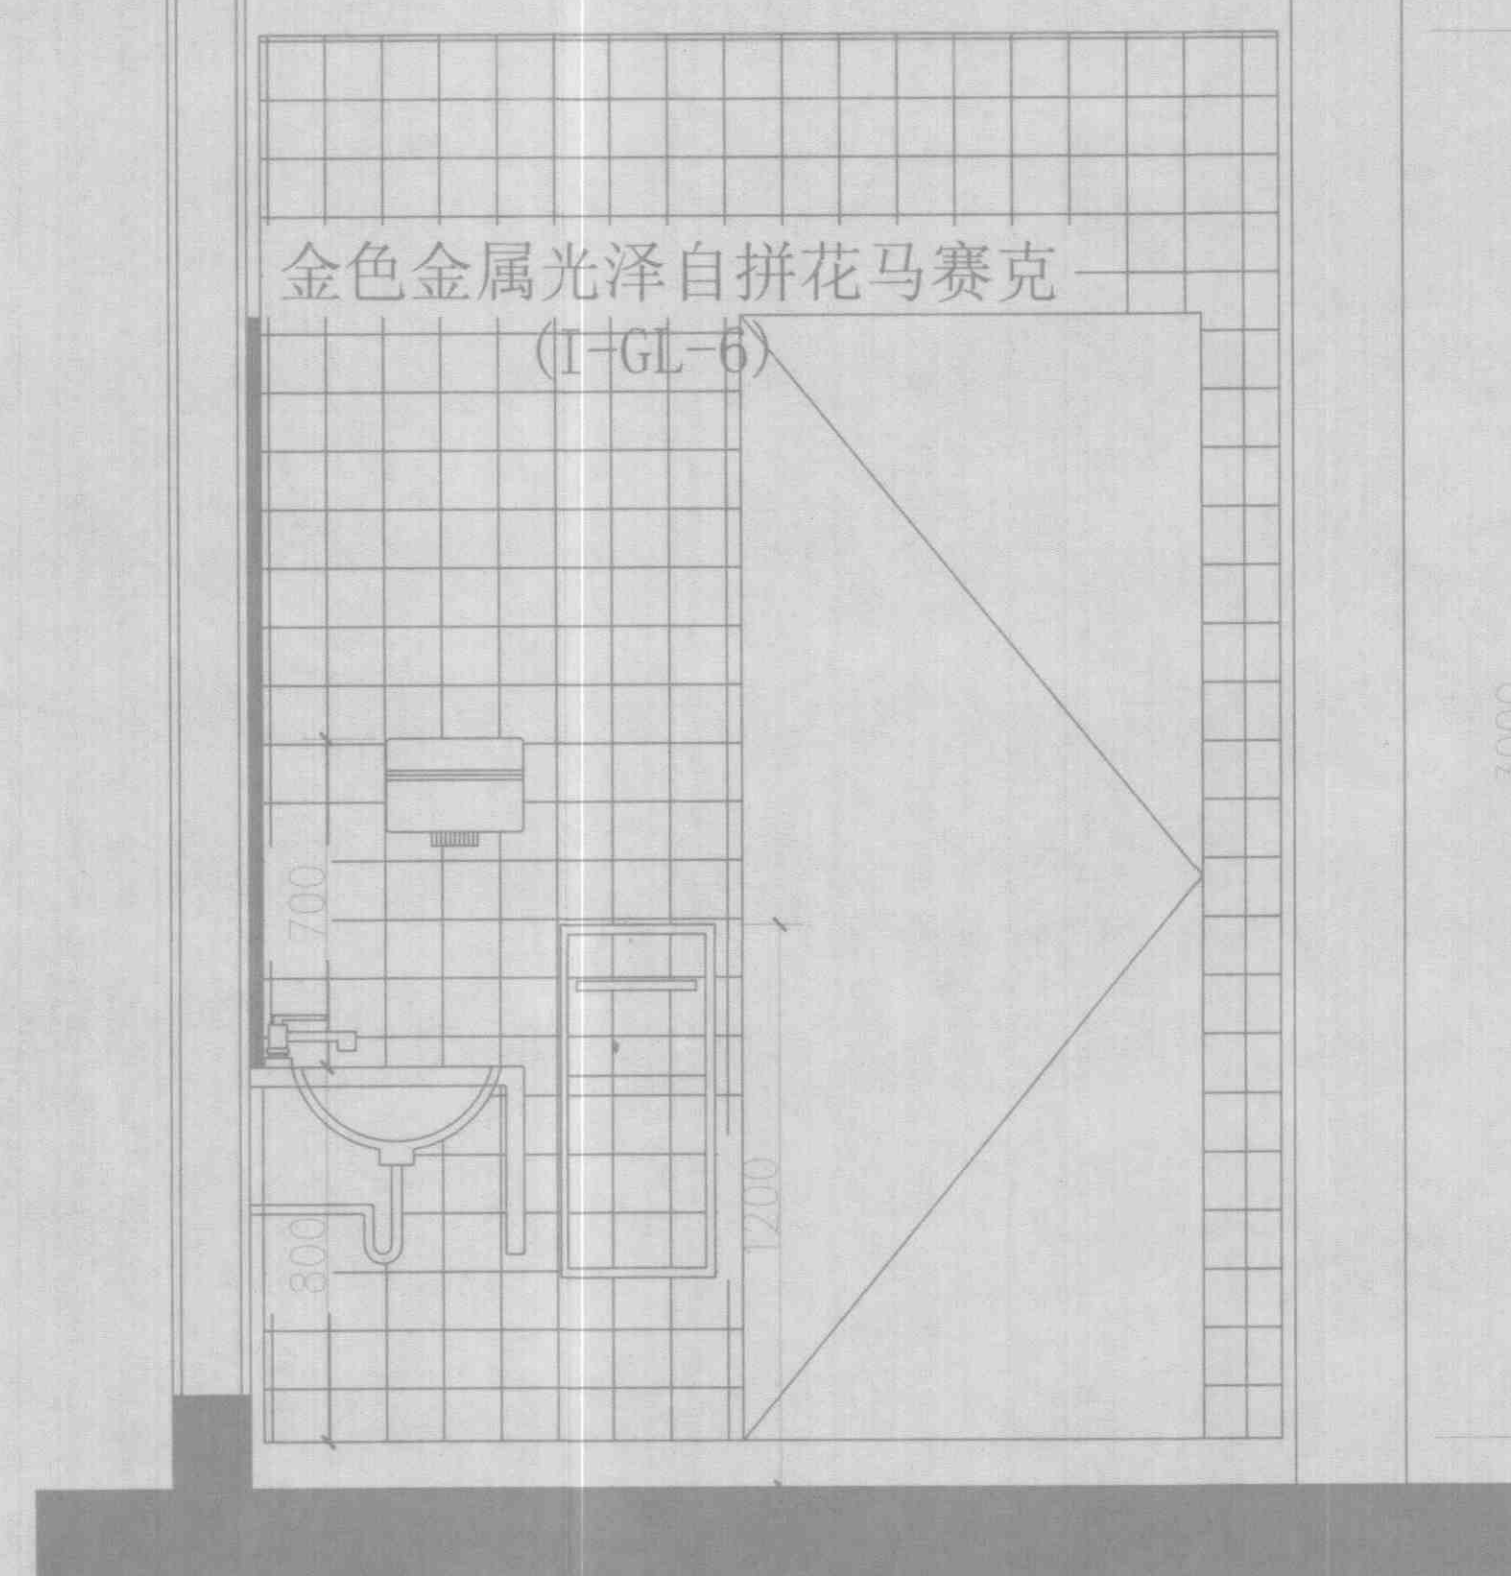

卫生间立面图  
1:30

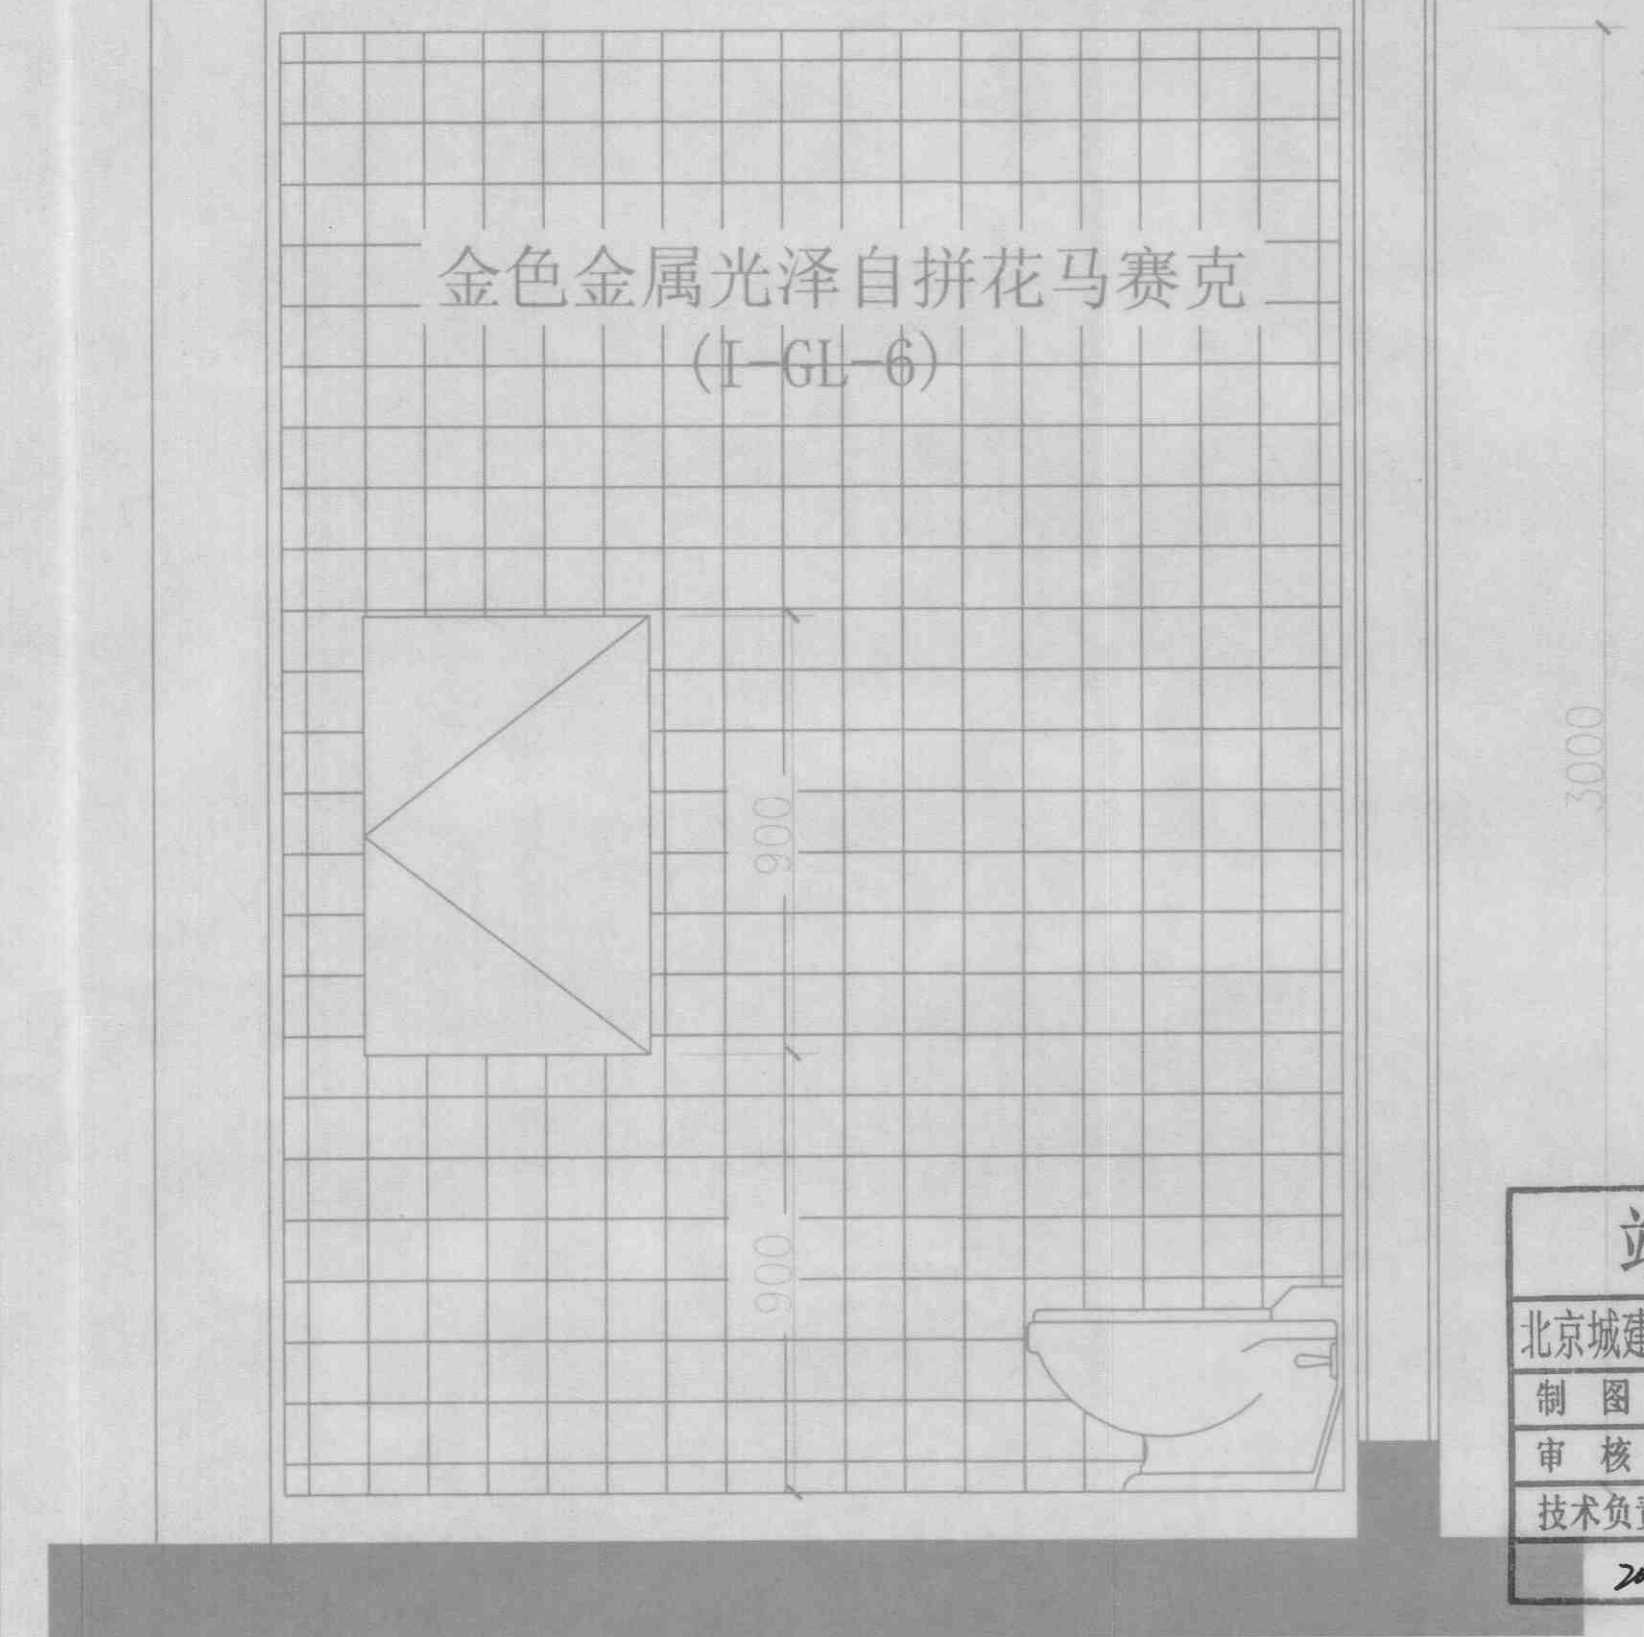

卫生间立面图  
1:30